

Houston, Texas 77004

UH Project No. : P770776

[illegible]

Seal/Signature

PRELIMINARY
These documents are incomplete
and not for regulatory approval,
permit or construction.


DAVID J. CALKINS
TEXAS ARCHITECT REGISTRATION # 11981
06/20/2011

Project Name	New Classroom and Business Building
Project Number	02.7044.000

Description	POWER & COMMUNICATION PLAN - LEVEL 3
-------------	---

Scale
As indicated

A1.33

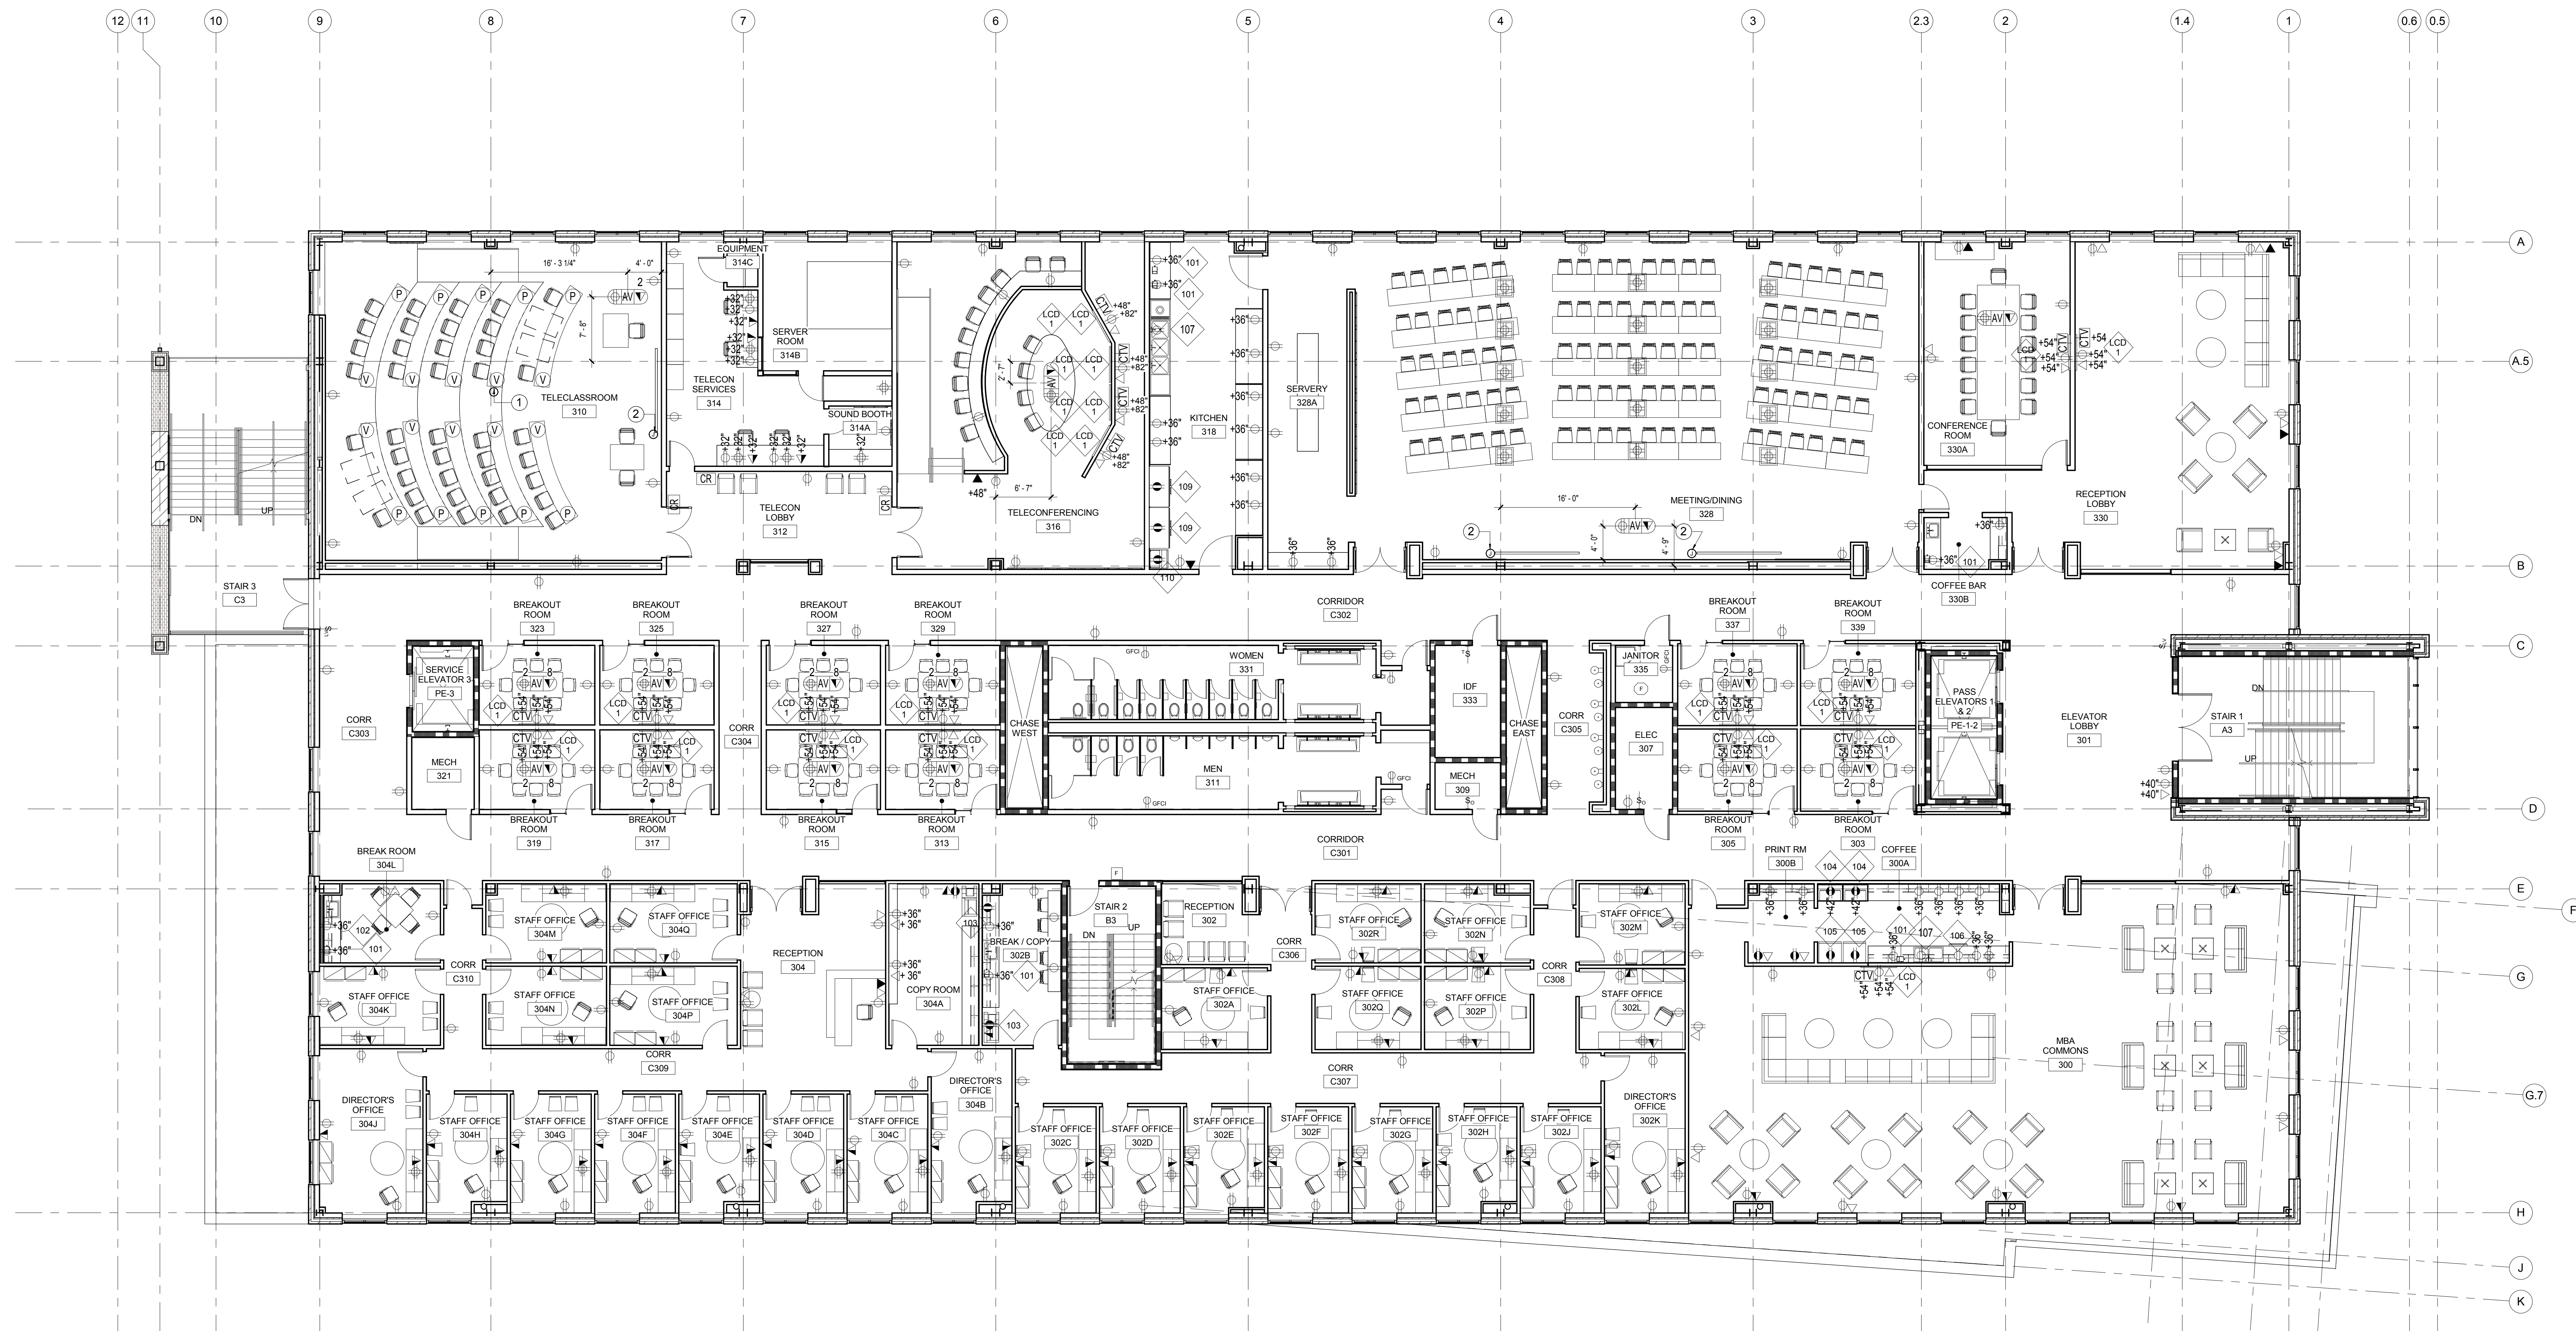

POWER & COMMUNICATION PLAN - LEVEL 3

SCALE: 1/8" = 1'-0"

- 1 J-BOX IN CEILING FOR PROJECTOR
2 J-BOX IN CEILING FOR PROJECTOR SCREEN

- A REFER TO A0.20 AND A0.21 FOR NOTES, SYMBOLS, LEGENDS, EQUIPMENT, MOUNTING HEIGHTS AND ALIGNMENTS, ETC. IN CONJUNCTION WITH THIS PLAN
- B REFER TO MEP FOR ADDITIONAL INFORMATION
- C FOR ALL OUTLETS LOCATED IN ACOUSTICAL WALLS, PROVIDE AND INSTALL 3M SOUND SEAL AROUND J-BOX
- D ALL OUTLETS AND PLATES TO BE WHITE
- E ALL LASER PRINTER AND COPIER OUTLETS TO BE DEDICATED CIRCUITS
- F REFER TO AV PLANS FOR DATA/CABLING INFORMATION AND COORDINATION

SHEET NOTES

GENERAL NOTES

NOTE: EVERY SHEETNOTE MAY NOT APPEAR ON THIS PAGE